


MARK	MANUFACTURER	MODEL	TRADE	QUANTITY	DESCRIPTION
A					REEL RECYCLED PENDANT LIGHT
B					ROUND PEND. BY SHIMMER
C					ROUND PEND. W/ GLASS
D					ROUND PEND. W/ GLASS
E					SHIMMER CHAIR STUCCO
F					SHIMMER CHAIR STUCCO
G					EXHAUST FAN W/ 120 LIGHT
H					EXHAUST FAN W/ 120 LIGHT
I					RECT. SHIMMER LIGHT
J					SHIMMER CHAIR STUCCO
K					SHIMMER CHAIR STUCCO
L					RECT. SHIMMER LIGHT
M					RECT. SHIMMER LIGHT
N					RECT. SHIMMER LIGHT
O					RECT. SHIMMER LIGHT
P					RECT. SHIMMER LIGHT
Q					RECT. SHIMMER LIGHT
R					RECT. SHIMMER LIGHT
S					RECT. SHIMMER LIGHT
T					RECT. SHIMMER LIGHT
U					RECT. SHIMMER LIGHT
V					RECT. SHIMMER LIGHT
W					RECT. SHIMMER LIGHT
X					RECT. SHIMMER LIGHT
Y					RECT. SHIMMER LIGHT
Z					RECT. SHIMMER LIGHT

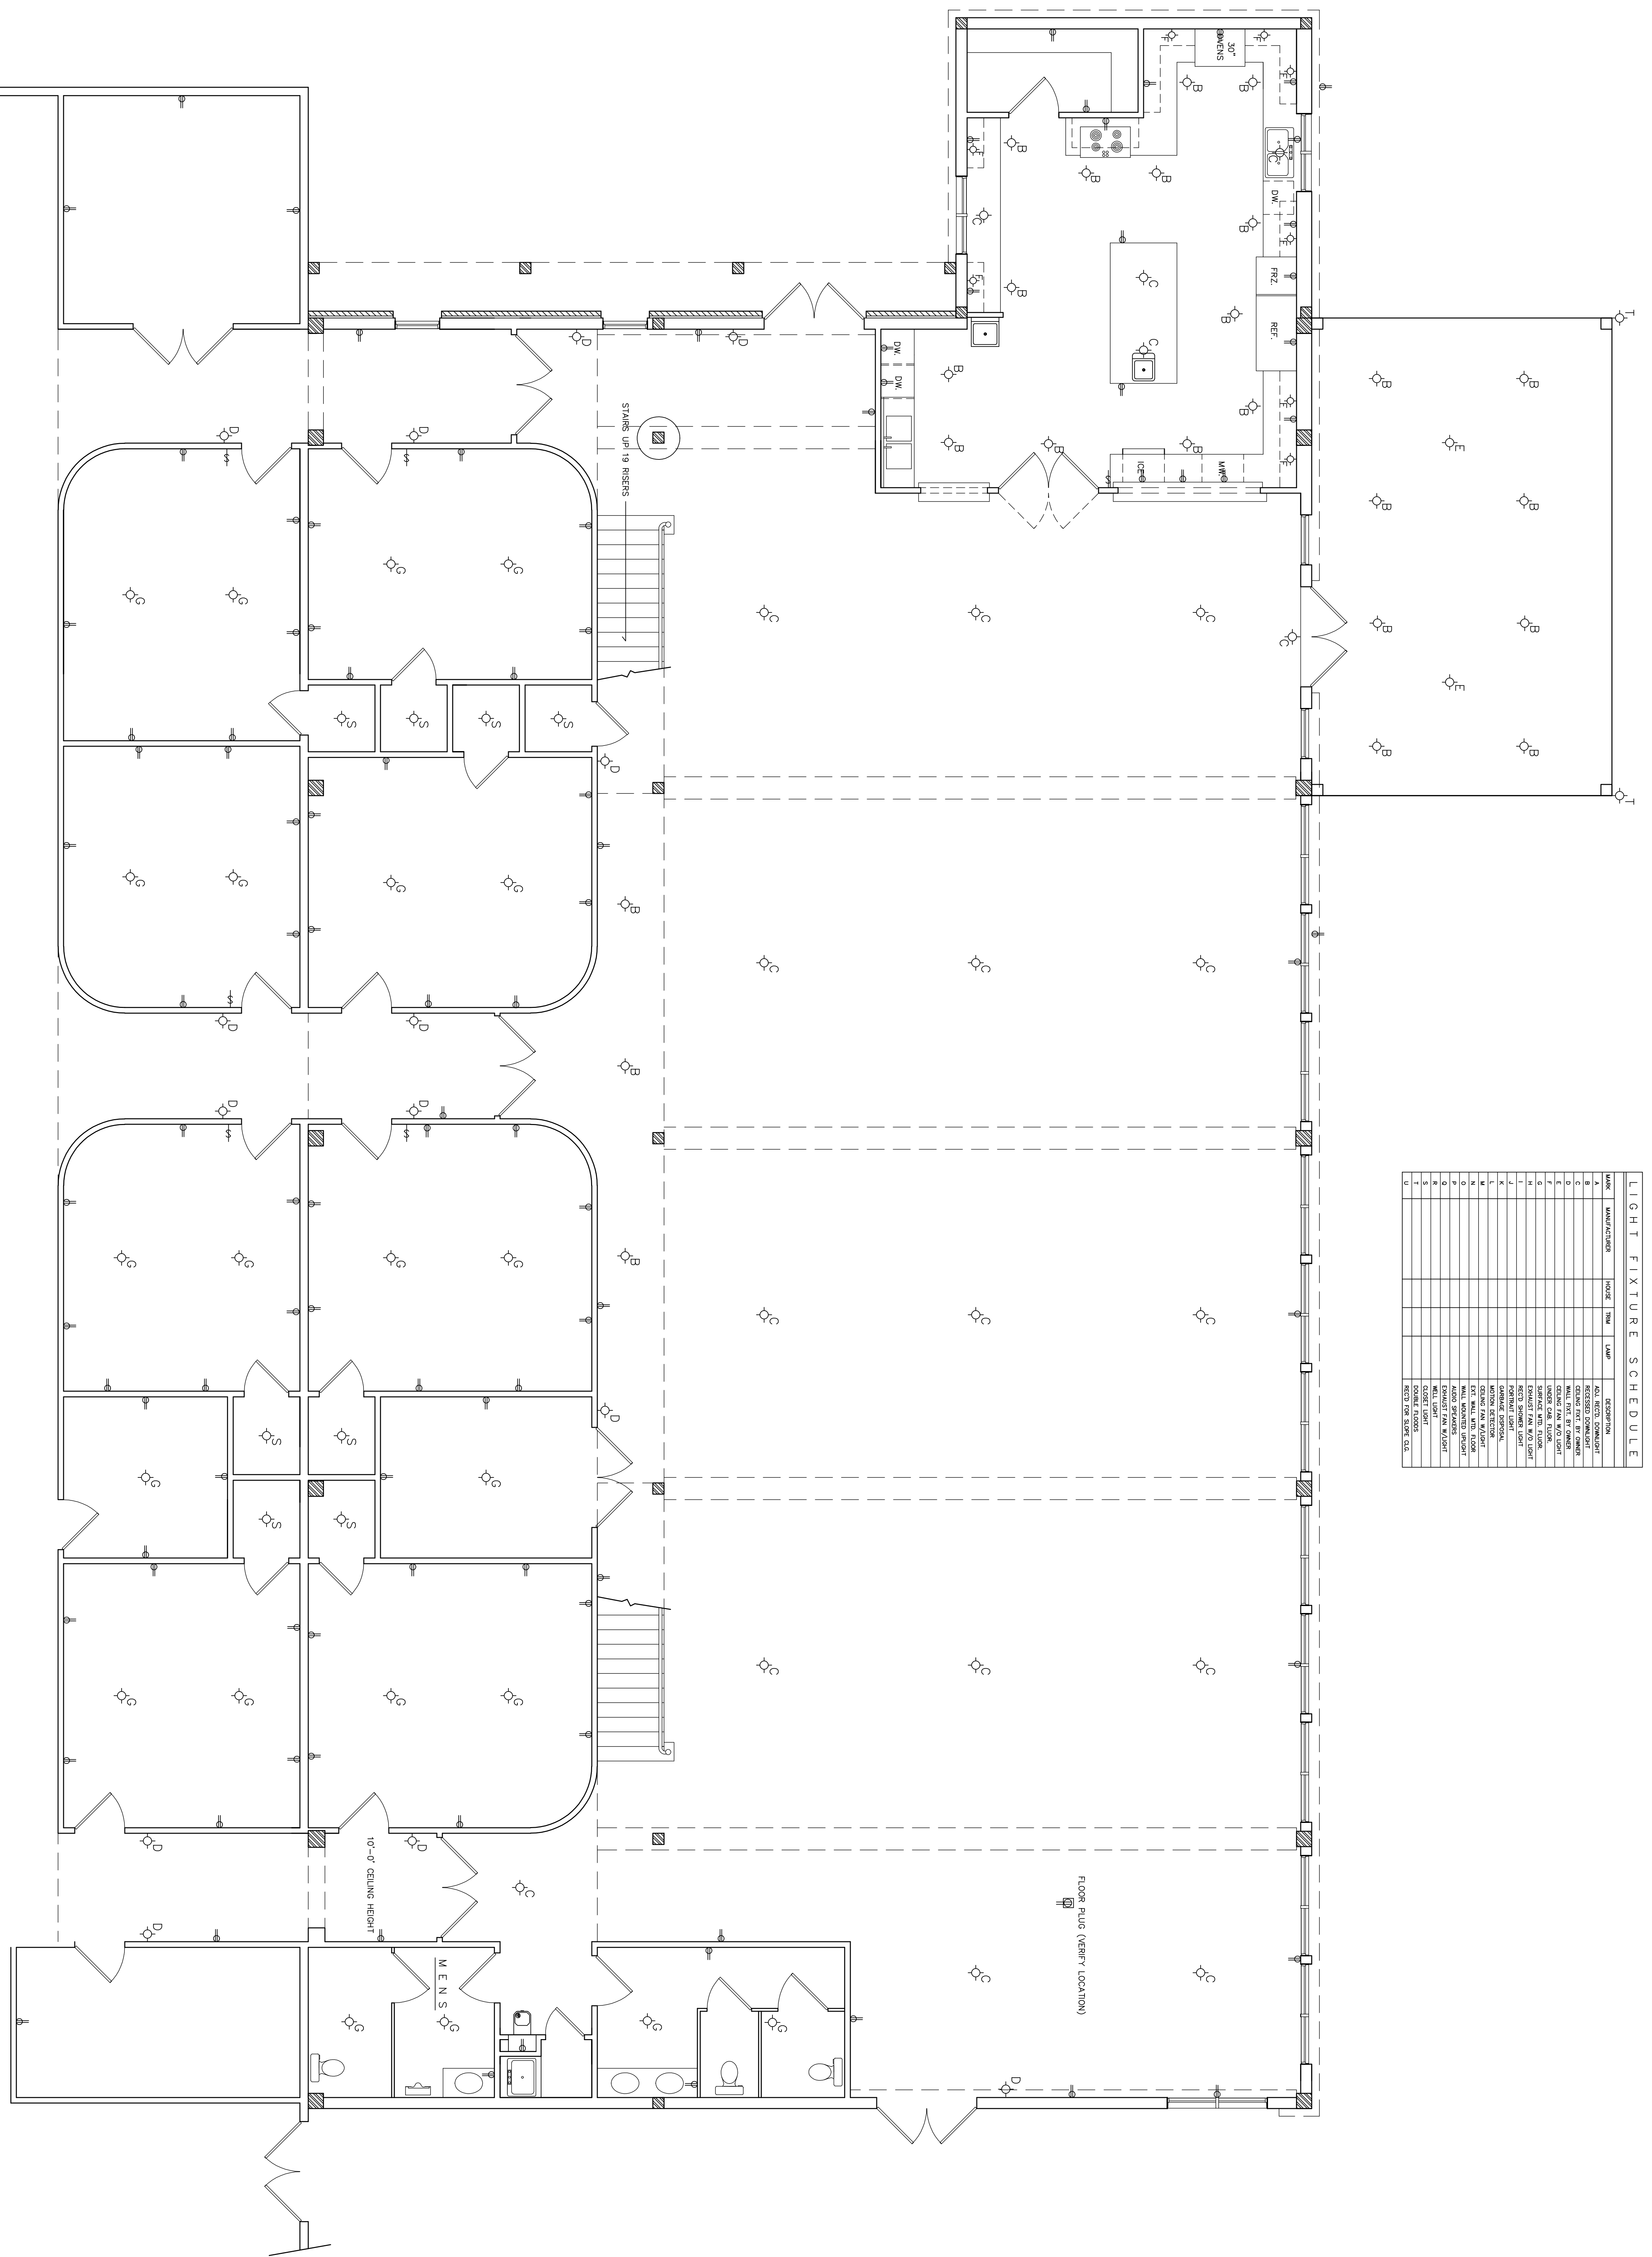

1
FIRST FLOOR LIGHTING AND ELECTRICAL PLAN
1 / 4 " = 1 ' - 0 "

I	SHEET NO. PROPOSED ADDITION FOR: NEW HOPE BAPTIST CHURCH ORE CITY TEXAS	DATE: JUNE 25, 2009 DRAWN BY: PROTO: REVISIONS: 1 2 3	GARY R. BORT DRAFTING & DESIGN SERVICE 1005 N. WHATLEY RD. WHITE OAK, TEXAS 903 759 0073	ELECTRICAL PLAN
----------	---	---	---	------------------------